



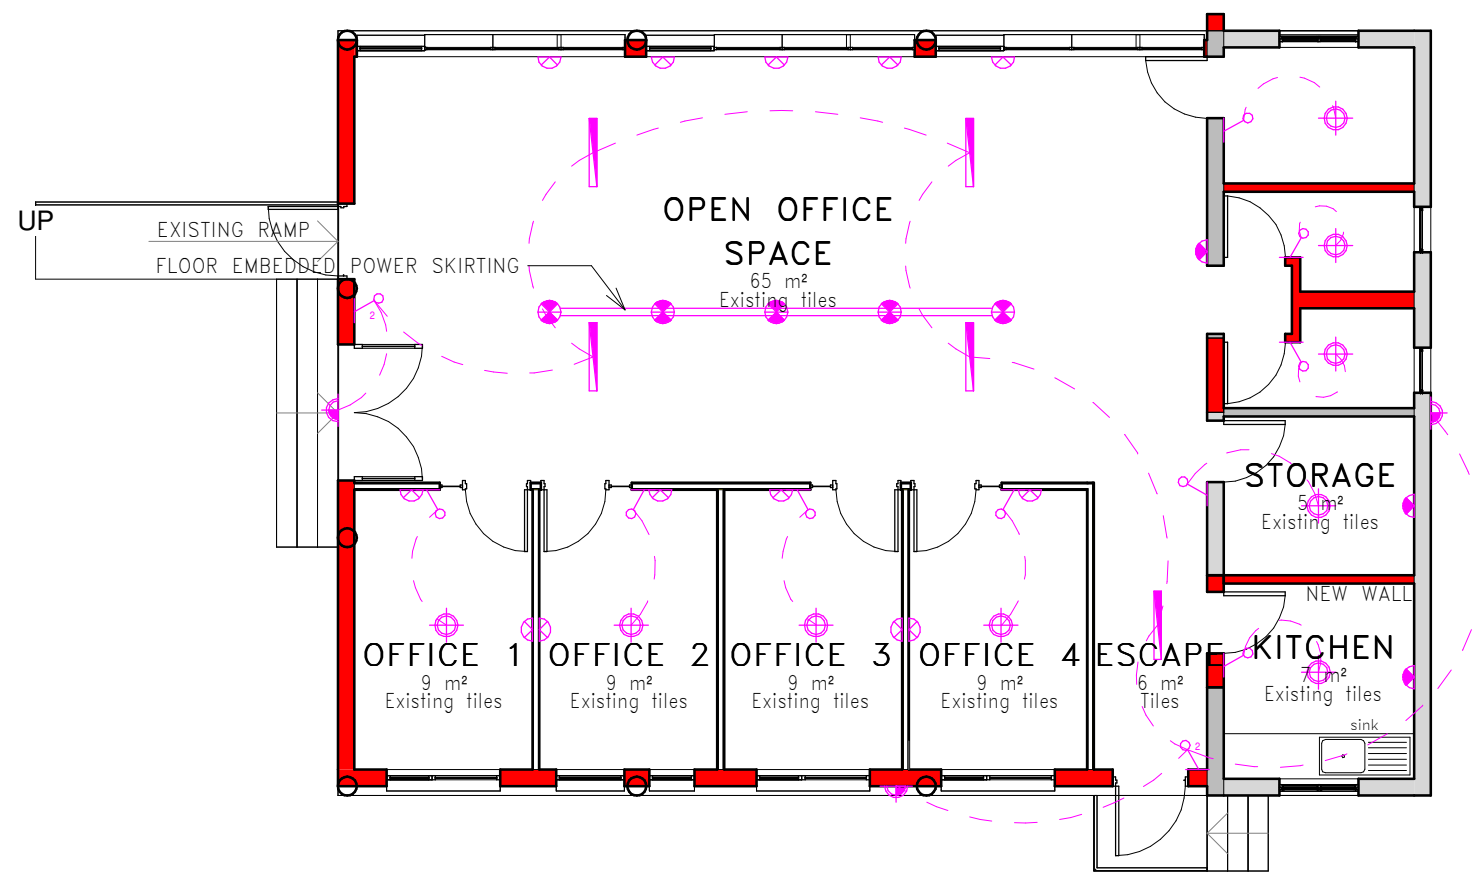

SYMBOL	DESCRIPTION
	18W LED FLORECENT LIGHT
	15W CEILING LIGHT
	20W LED FLOOD LIGHT
	DOUBLE PLUG SOCKET 900mm ABOVE FFL
	DOUBLE PLUG SOCKET 350mm ABOVE FFL
	FLOOR EMBEDDED MODULAR FLOOR SOCKET
	ONE-WAY LIGHT SWITCH
	TWO-WAY LIGHT SWITCH

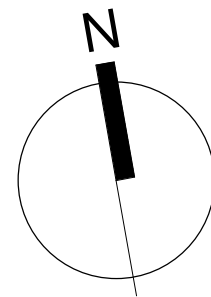

ELECTRICAL LAYOUT PLAN

SCALE 1 : 100

No.	DATE	REVISION

Copyright vests in KWP. All Rights Reserved.

project description	
REFURBISHMENT OF AN EXISTING LAPA	
SANBI_	
Pretoria National Botenical Gardens	
drawing title	drawing number
ELECTRICAL LAYOUT PLAN	23.33/202
date	drawn
08/11/2024	TN